


TENANT FIT OUT

749 WEST SIDE AVE JERSEY CITY, NJ 07306

ZONING ANALYSIS		BLOCK: 16102	LOT: 14	
NC ZONING REQUIREMENTS	REQUIRED	PROPOSED	COMPLIES	
MINIMUM LOT DIMENSIONS	AREA (SQFT)	2,500	4,522	YES/NO CHANGE
	WIDTH (FT)	25	34	YES/NO CHANGE
	DEPTH (FT)	100	133	YES/NO CHANGE
MINIMUM YARD SETBACKS	FRONT (FT)	0	0	YES/NO CHANGE
	REAR (FT)	30	48	YES
	SIDE (FT)	0	0	YES/NO CHANGE
MAXIMUM HEIGHT	55 FT, 5 STORIES	41 FT, 4 STORIES	YES/NO CHANGE	
MINIMUM CEILING HEIGHT	GROUND FLOOR	11 FT	NO CHANGE	YES/NO CHANGE
	UPPER FLOORS	9 FT	NO CHANGE	YES/NO CHANGE
PARKING REQUIRED (SPACES)	0	0	YES/NO CHANGE	
MAXIMUM BUILDING COVERAGE	N/A	42%	YES/NO CHANGE	
MAXIMUM IMPERVIOUS COVERAGE	N/A	42%	YES/NO CHANGE	
GROSS FLOOR AREA - COMMERCIAL (SF)	1,902	NO CHANGE	YES/NO CHANGE	
GROSS FLOOR AREA - RESIDENTIAL (SF)	5,748	NO CHANGE	YES/NO CHANGE	
GROSS FLOOR AREA - TOTAL (SF)	7,650	NO CHANGE	YES/NO CHANGE	
SIGNAGE (GROUND FLOOR)	20 SF OR 5% OF 1ST FL GSF, WHICHEVER IS SMALLER	18.75 SF	YES	

SHEET LIST			
PAGE #			PLANNING BOARD SET
1	T-100.00	COVER PAGE- BUILDING, CODE & ZONING INFO	*
2	A-101.00	PROPOSED PLAN & ELEVATION	*
3	A-102.00	PROPOSED LIGHTING PLAN & FIXTURE SCHEDULE	*

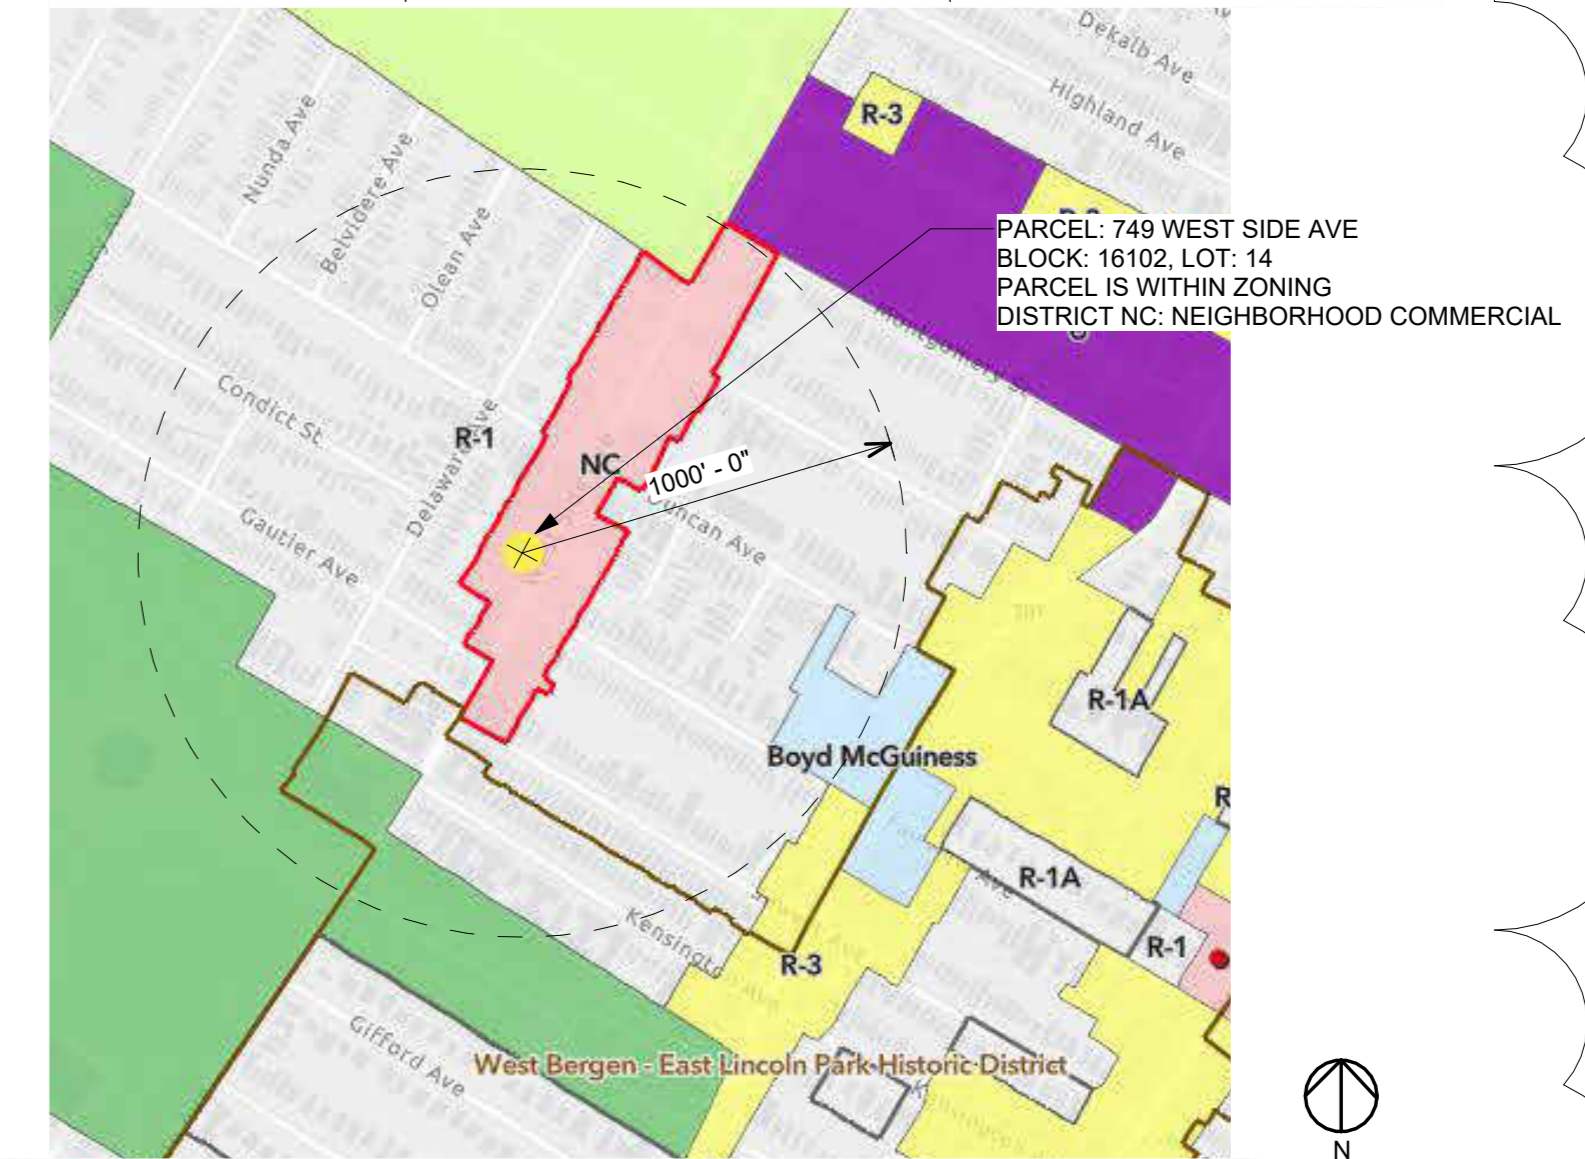

1 ZONING MAP
1"=500'

SCOPE OF WORK

DOCUMENTS FOR PLANNING BOARD APPROVAL OF A MICRO BUSINESS LICENSE TO PERMIT TENANT FIT OUT OF AN EXISTING COMMERCIAL SPACE INTO A CANNABIS RETAIL STORE

CODE INFORMATION

ALL MATERIALS AND CONSTRUCTION TECHNIQUES SHALL BE IN ACCORDANCE WITH THE FOLLOWING APPLICABLE CODES:

2018 INTERNATIONAL BUILDING CODE, NJ EDITION
2018 NATIONAL STANDARD PLUMBING CODE, NJ EDITION
2017 NATIONAL ELECTRICAL CODE (NFPA 70)
ASHRAE 90.1-2016 ENERGY SUBCODE
2018 INTERNATIONAL MECHANICAL CODE
2018 INTERNATIONAL FUEL GAS CODE
NJCC REHABILITATION SUBCODE, SUBCHAPTER 6
ANSI A117.1-2009 BARRIER FREE SUBCODE

BUILDING DATA

CONSTRUCTION TYPE: IIIIB
USE GROUP: M
NUMBER OF STORIES: 4
EXISTING/PROPOSED TENANT UNIT AREA: 1,540 SF
BUILDING IS NON-SPRINKLERED
PERMITTED MAXIMUM TRAVEL DISTANCE: 200 FT (NON-SPRINKLERED); COMPLIES

OCCUPANCY CALCULATIONS

-OCCUPANT LOAD: TOTAL AREA = 1,540 sf
TABLE 1004.5: 60 SF GROSS PER OCCUPANT FOR MERCANTILE (300 AT STORAGE):
150SF/300 = 1 OCCUPANT AT STORAGE AREA
1390SF/60SF = 23 OCCUPANTS AT REST OF TENANT AREA
TOTAL = 24 OCCUPANTS


-AS PER (TABLE 1006.3.2) MIN. 2 EXITS ARE REQUIRED:
EXITS PROVIDED = 3

-AS PER TABLE 1017.2, MAX OF 200' EXIT ACCESS TRAVEL DISTANCE
PATH A TRAVEL DISTANCE = 29' - 9"
PATH B TRAVEL DISTANCE = 64' - 10"
PATH C TRAVEL DISTANCE = 36' - 0"



3 EXISTING FACADE IMAGE
NTS

Lawrence
Architecture
LLC

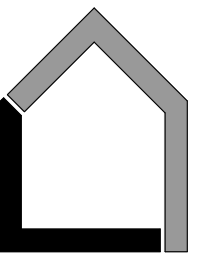

100 Walnut Ave, Suite 210
Clark, NJ 07066
(646) 737-4769
david@lawrencearchitects.com

CONSULTANTS:

MEP ENGINEER
RUPAL SINGH, P.E.

THIS DOCUMENT AND ALL INFORMATION HEREIN IS THE EXCLUSIVE PROPERTY OF LAWRENCE ARCHITECTURE LLC. THIS DOCUMENT AND THE INFORMATION IT CONTAINS MAY NOT BE REPRODUCED OR USED OTHER THAN THE SPECIFIC PROJECT IT WAS PREPARED FOR.

TENANT FIT OUT
749 WEST SIDE AVE
JERSEY CITY, NJ 07306
BLOCK: 16102; LOT: 14

OWNER:

WHITE LOTUS DISPENSARY, LLC
201-565-2415
LOTUSDISP@GMAIL.COM

SUBMISSIONS:

PLANNING REVIEW 01/02/2022

REVISIONS:

PLANNING COMMENTS 04/20/2023




ARCHITECT LICENSE NUMBER:
DAVID M. LAWRENCE NY 043270
DAVID M. LAWRENCE NJ 21A02186600

COVER PAGE-
BUILDING, CODE &
ZONING INFO

SHEET NUMBER

T-100.00

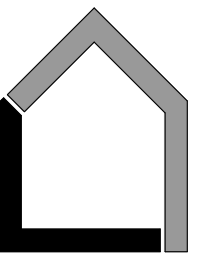

CONSULTANTS:

MEP ENGINEER
RUPAL SINGH, P.E.

THIS DOCUMENT AND ALL
INFORMATION HEREIN IS THE
EXCLUSIVE PROPERTY OF
LAWRENCE ARCHITECTURE LLC.
THIS DOCUMENT AND THE
INFORMATION IT CONTAINS MAY
NOT BE REPRODUCED OR USED
OTHER THAN THE SPECIFIC
PROJECT IT WAS PREPARED FOR.

TENANT FIT OUT
749 WEST SIDE AVE
JERSEY CITY, NJ 07306
BLOCK: 16102; LOT: 14

OWNER:

WHITE LOTUS DISPENSARY, LLC
201-565-2415
LOTUSDISP@GMAIL.COM

SUBMISSIONS:

PLANNING REVIEW 01/02/2022

REVISIONS:

PLANNING COMMENTS 04/20/2023





ARCHITECT LICENSE NUMBER:
DAVID M. LAWRENCE NJ 043270
DAVID M. LAWRENCE NJ 21A02186600

PROPOSED PLAN &
ELEVATION



SHEET NUMBER


A-101.00

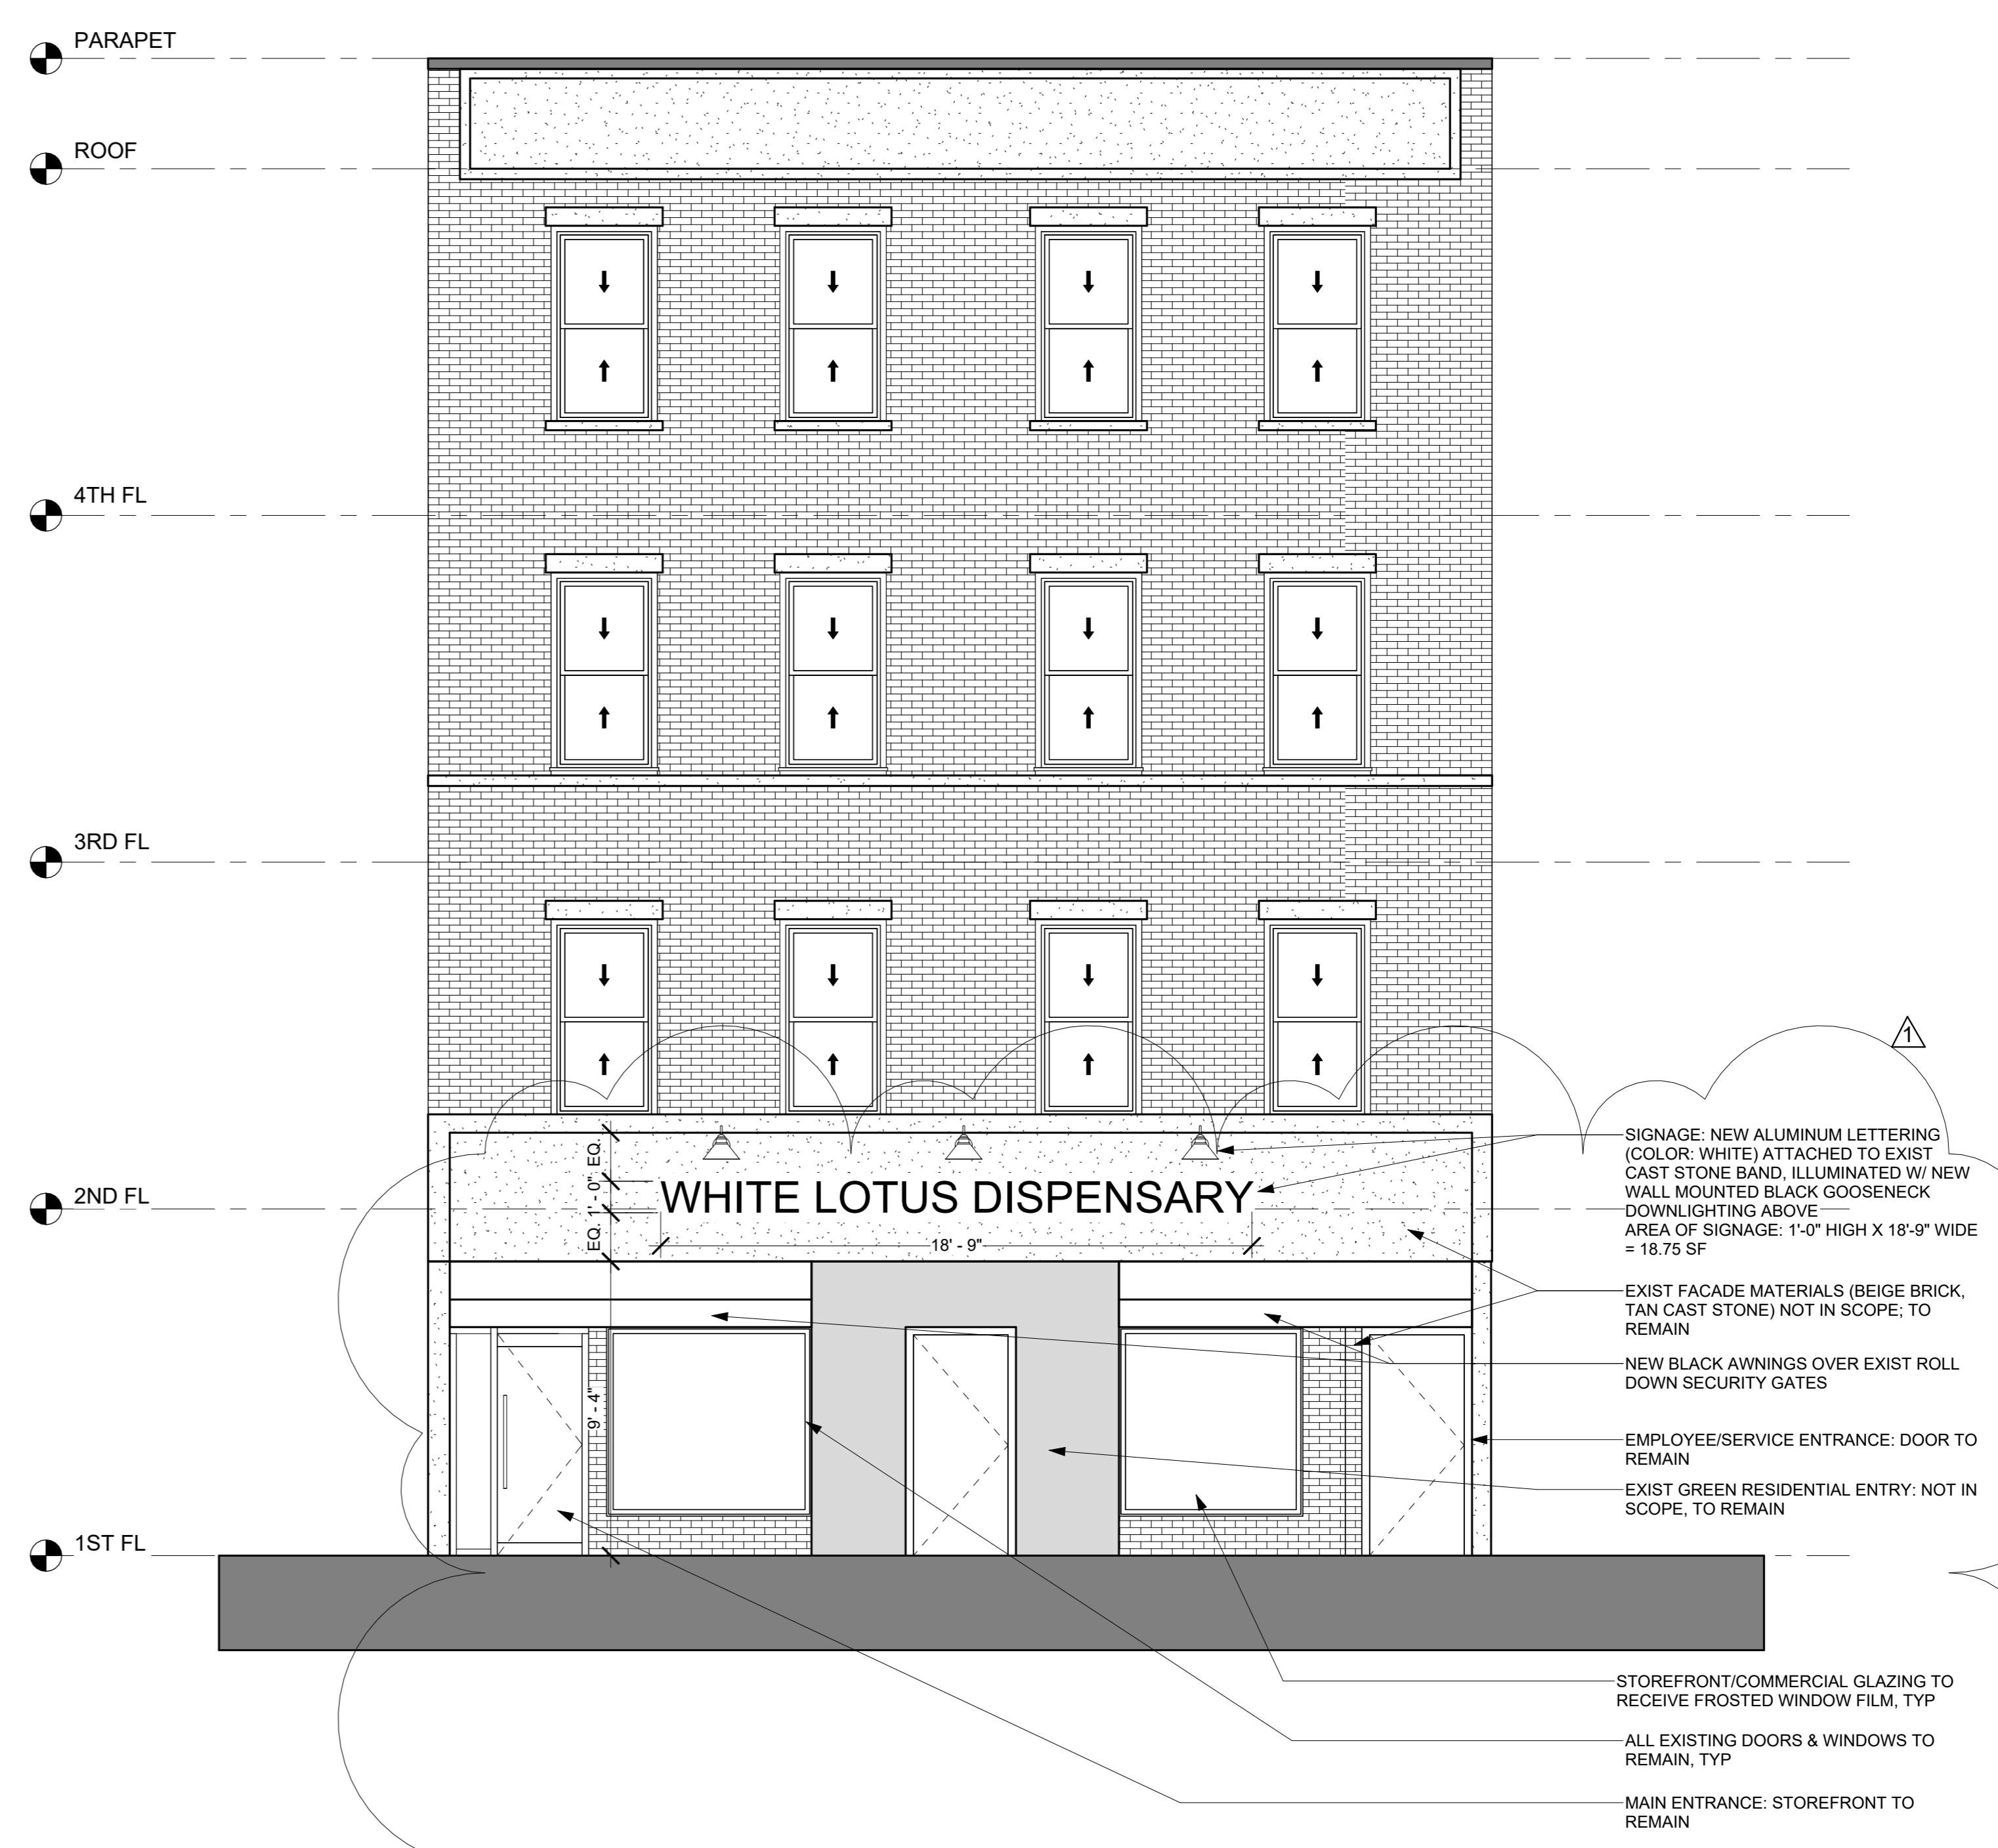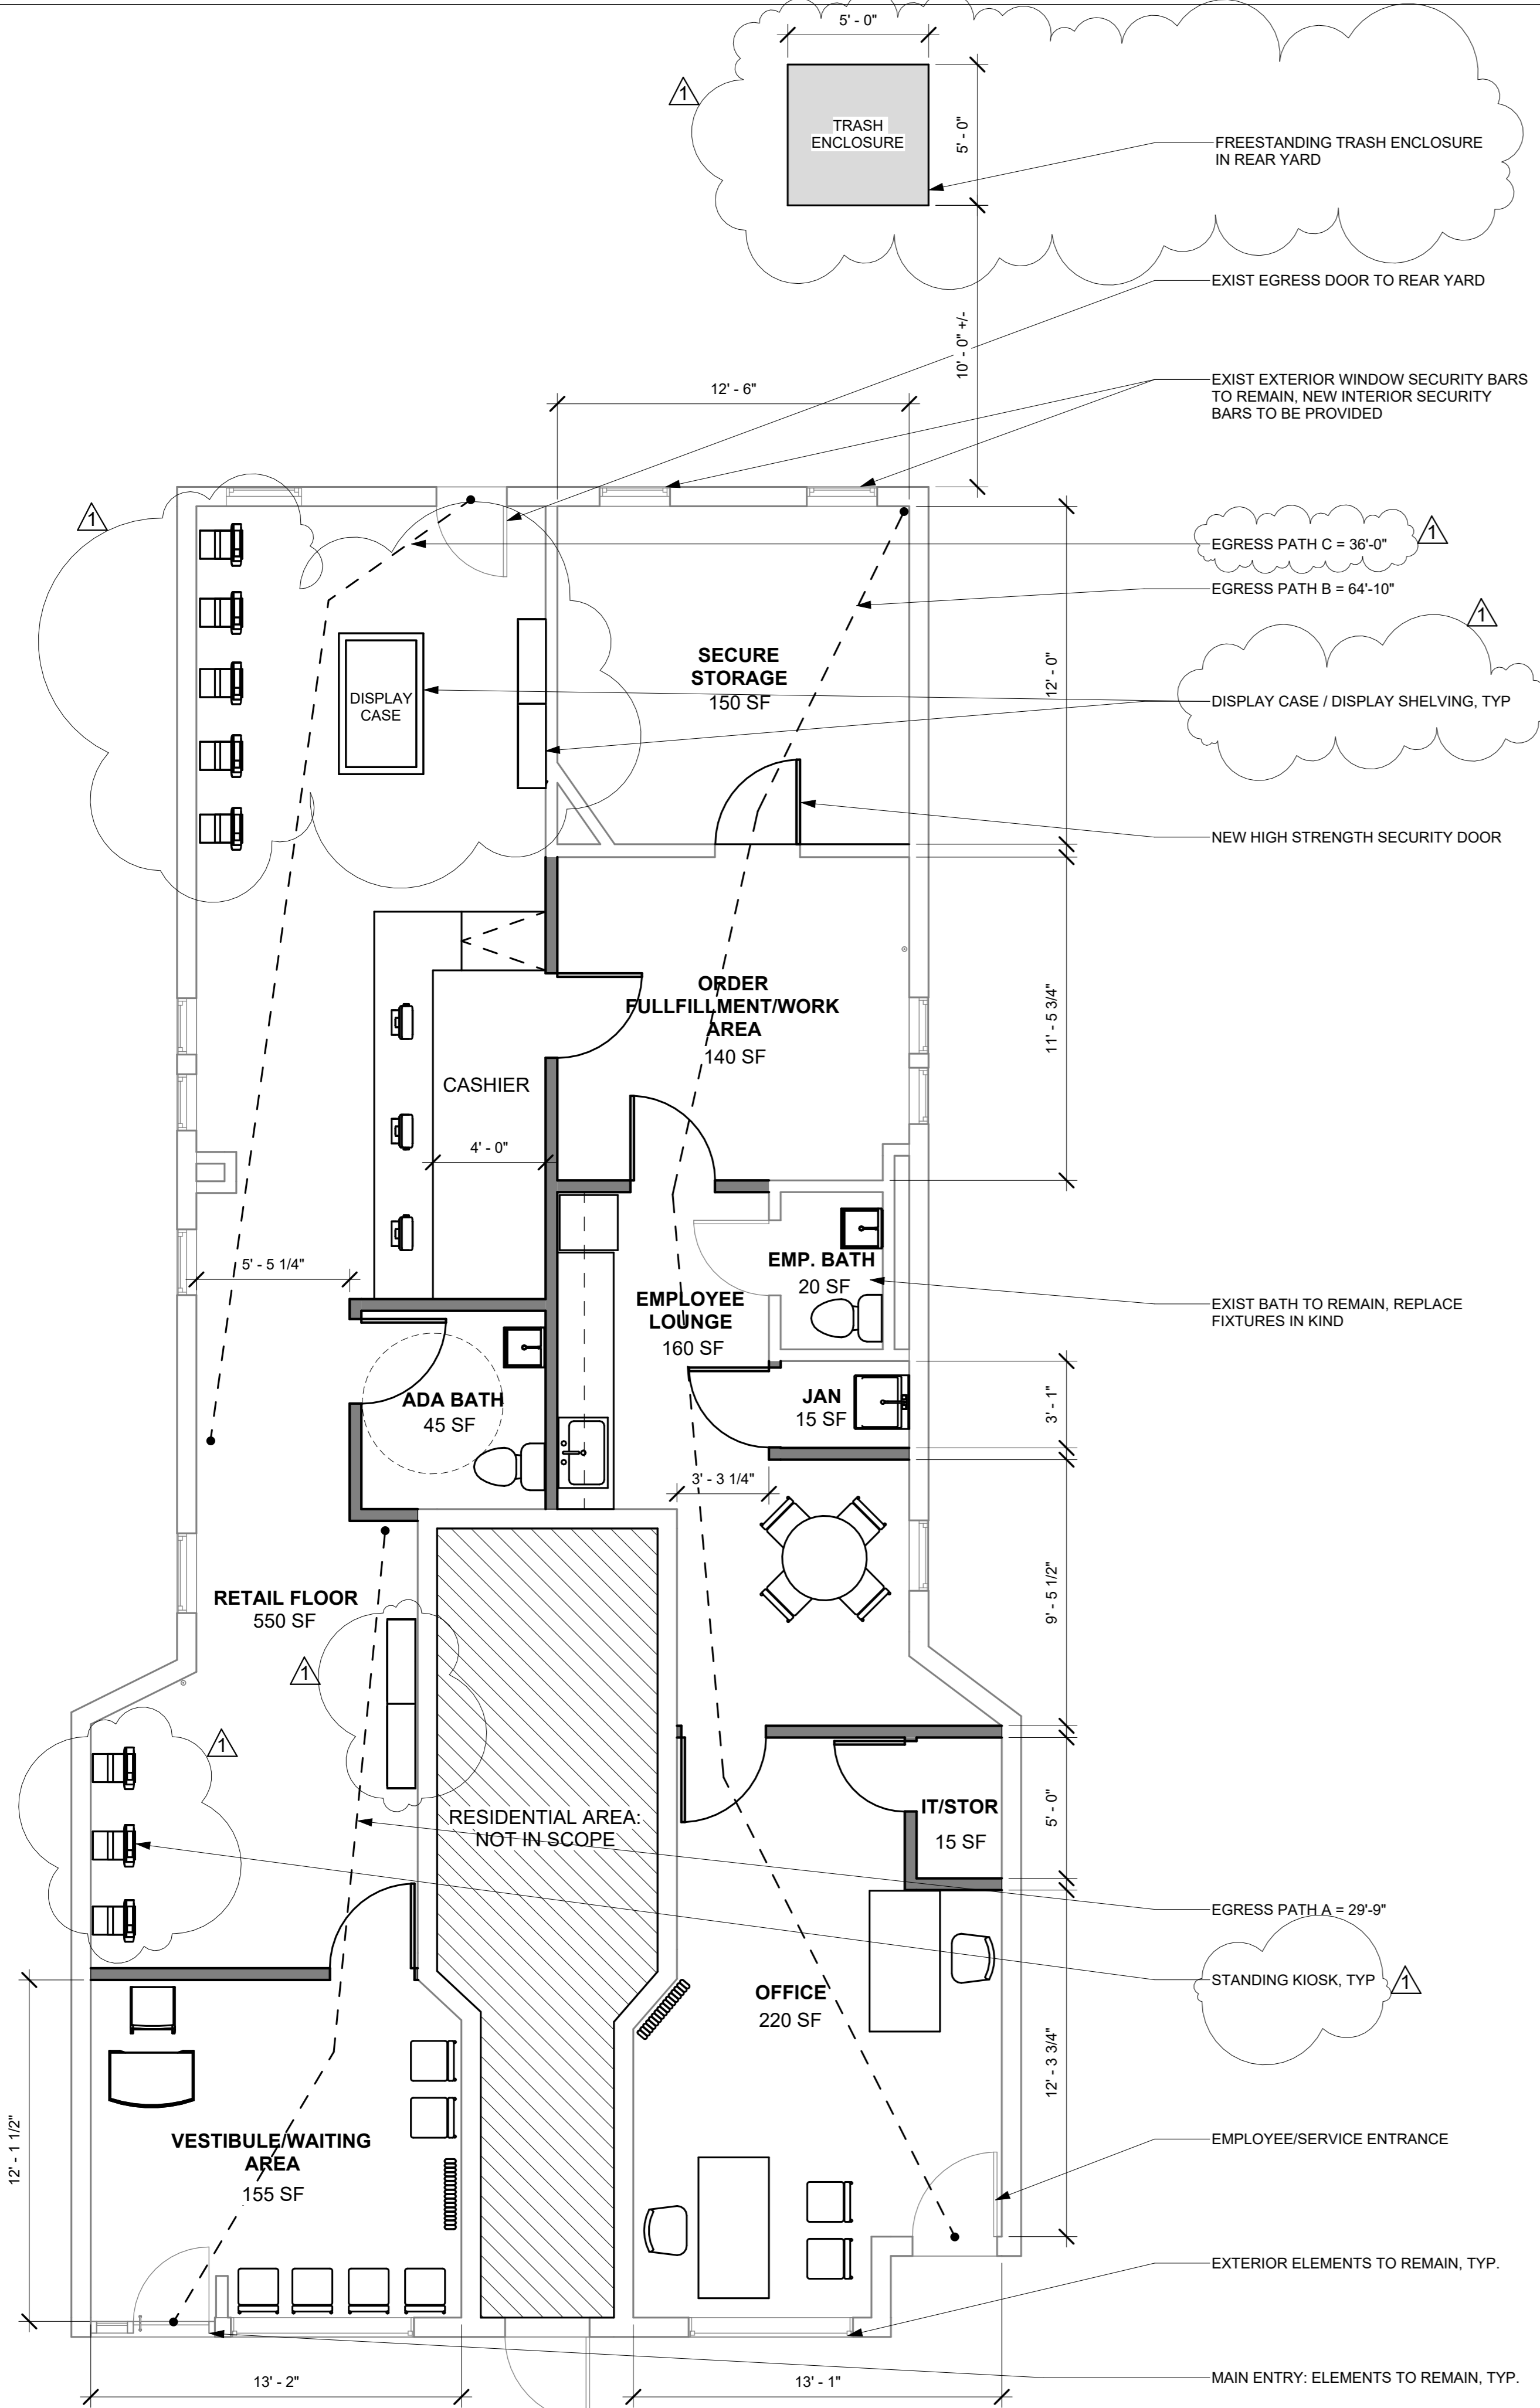

1 FIRST FLOOR - PROPOSED PLAN
1/4" = 1'-0"

2 FACADE ELEVATION
1/4" = 1'-0"

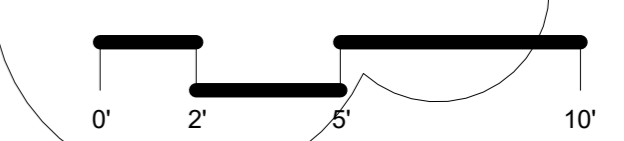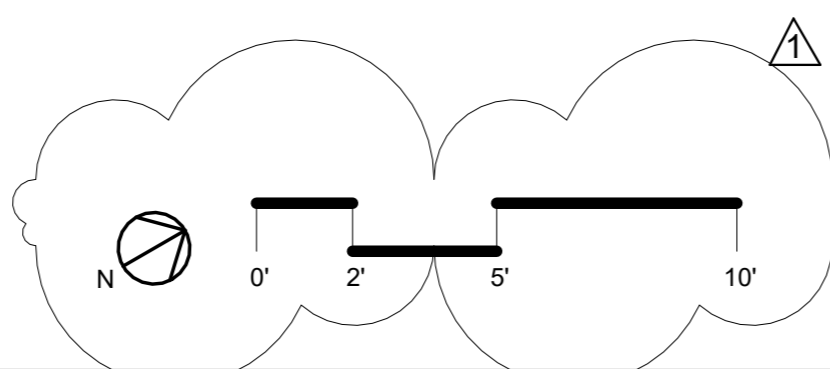

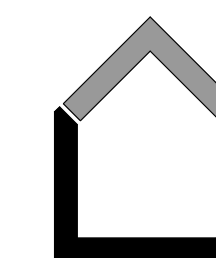

CONSULTANTS:

MEP ENGINEER
RUPAL SINGH, P.E.

THIS DOCUMENT AND ALL
INFORMATION HEREIN IS THE
EXCLUSIVE PROPERTY OF
LAWRENCE ARCHITECTURE LLC.
THIS DOCUMENT AND THE
INFORMATION IT CONTAINS MAY
NOT BE REPRODUCED OR USED
OTHER THAN THE SPECIFIC
PROJECT IT WAS PREPARED FOR.

TENANT FIT OUT
749 WEST SIDE AVE
JERSEY CITY, NJ 07306
BLOCK: 16102, LOT: 14

OWNER:

WHITE LOTUS DISPENSARY, LLC
201-565-2415
LOTUSDISP@GMAIL.COM

SUBMISSIONS:

PLANNING REVIEW 01/02/2022

REVISIONS:

▲ PLANNING COMMENTS 04/20/2023





ARCHITECT LICENSE NUMBER: 043270
DAVID M. LAWRENCE NY 21A02186600
DAVID M. LAWRENCE NJ

PROPOSED LIGHTING
PLAN & FIXTURE
SCHEDULE

SHEET NUMBER

A-102.00

LIGHT FIXTURE SCHEDULE							
FIXTURE	TYPE	MAKE	MODEL	SIZE	WATTS	# OF FIXTURES	TOTAL WATTS
L-01	RECESSED DOWNLIGHT - LED	WAC LIGHTING	R4FRDT-927-WT	4"	13	45	585
L-02	LINEAR FLUSH MOUNT - LED	LITHONIA LIGHTING	CSS-L48-4000LM-MVOLT-4000K-80CRI	48"	35.3	8	282.4
L-03	SIGNAGE DOWNLIGHT - LED	RAB LIGHTING	GN1LED-26-N-R-AD-11-B	11"	26	3	78
						GRAND TOTAL WATTS	945.4

 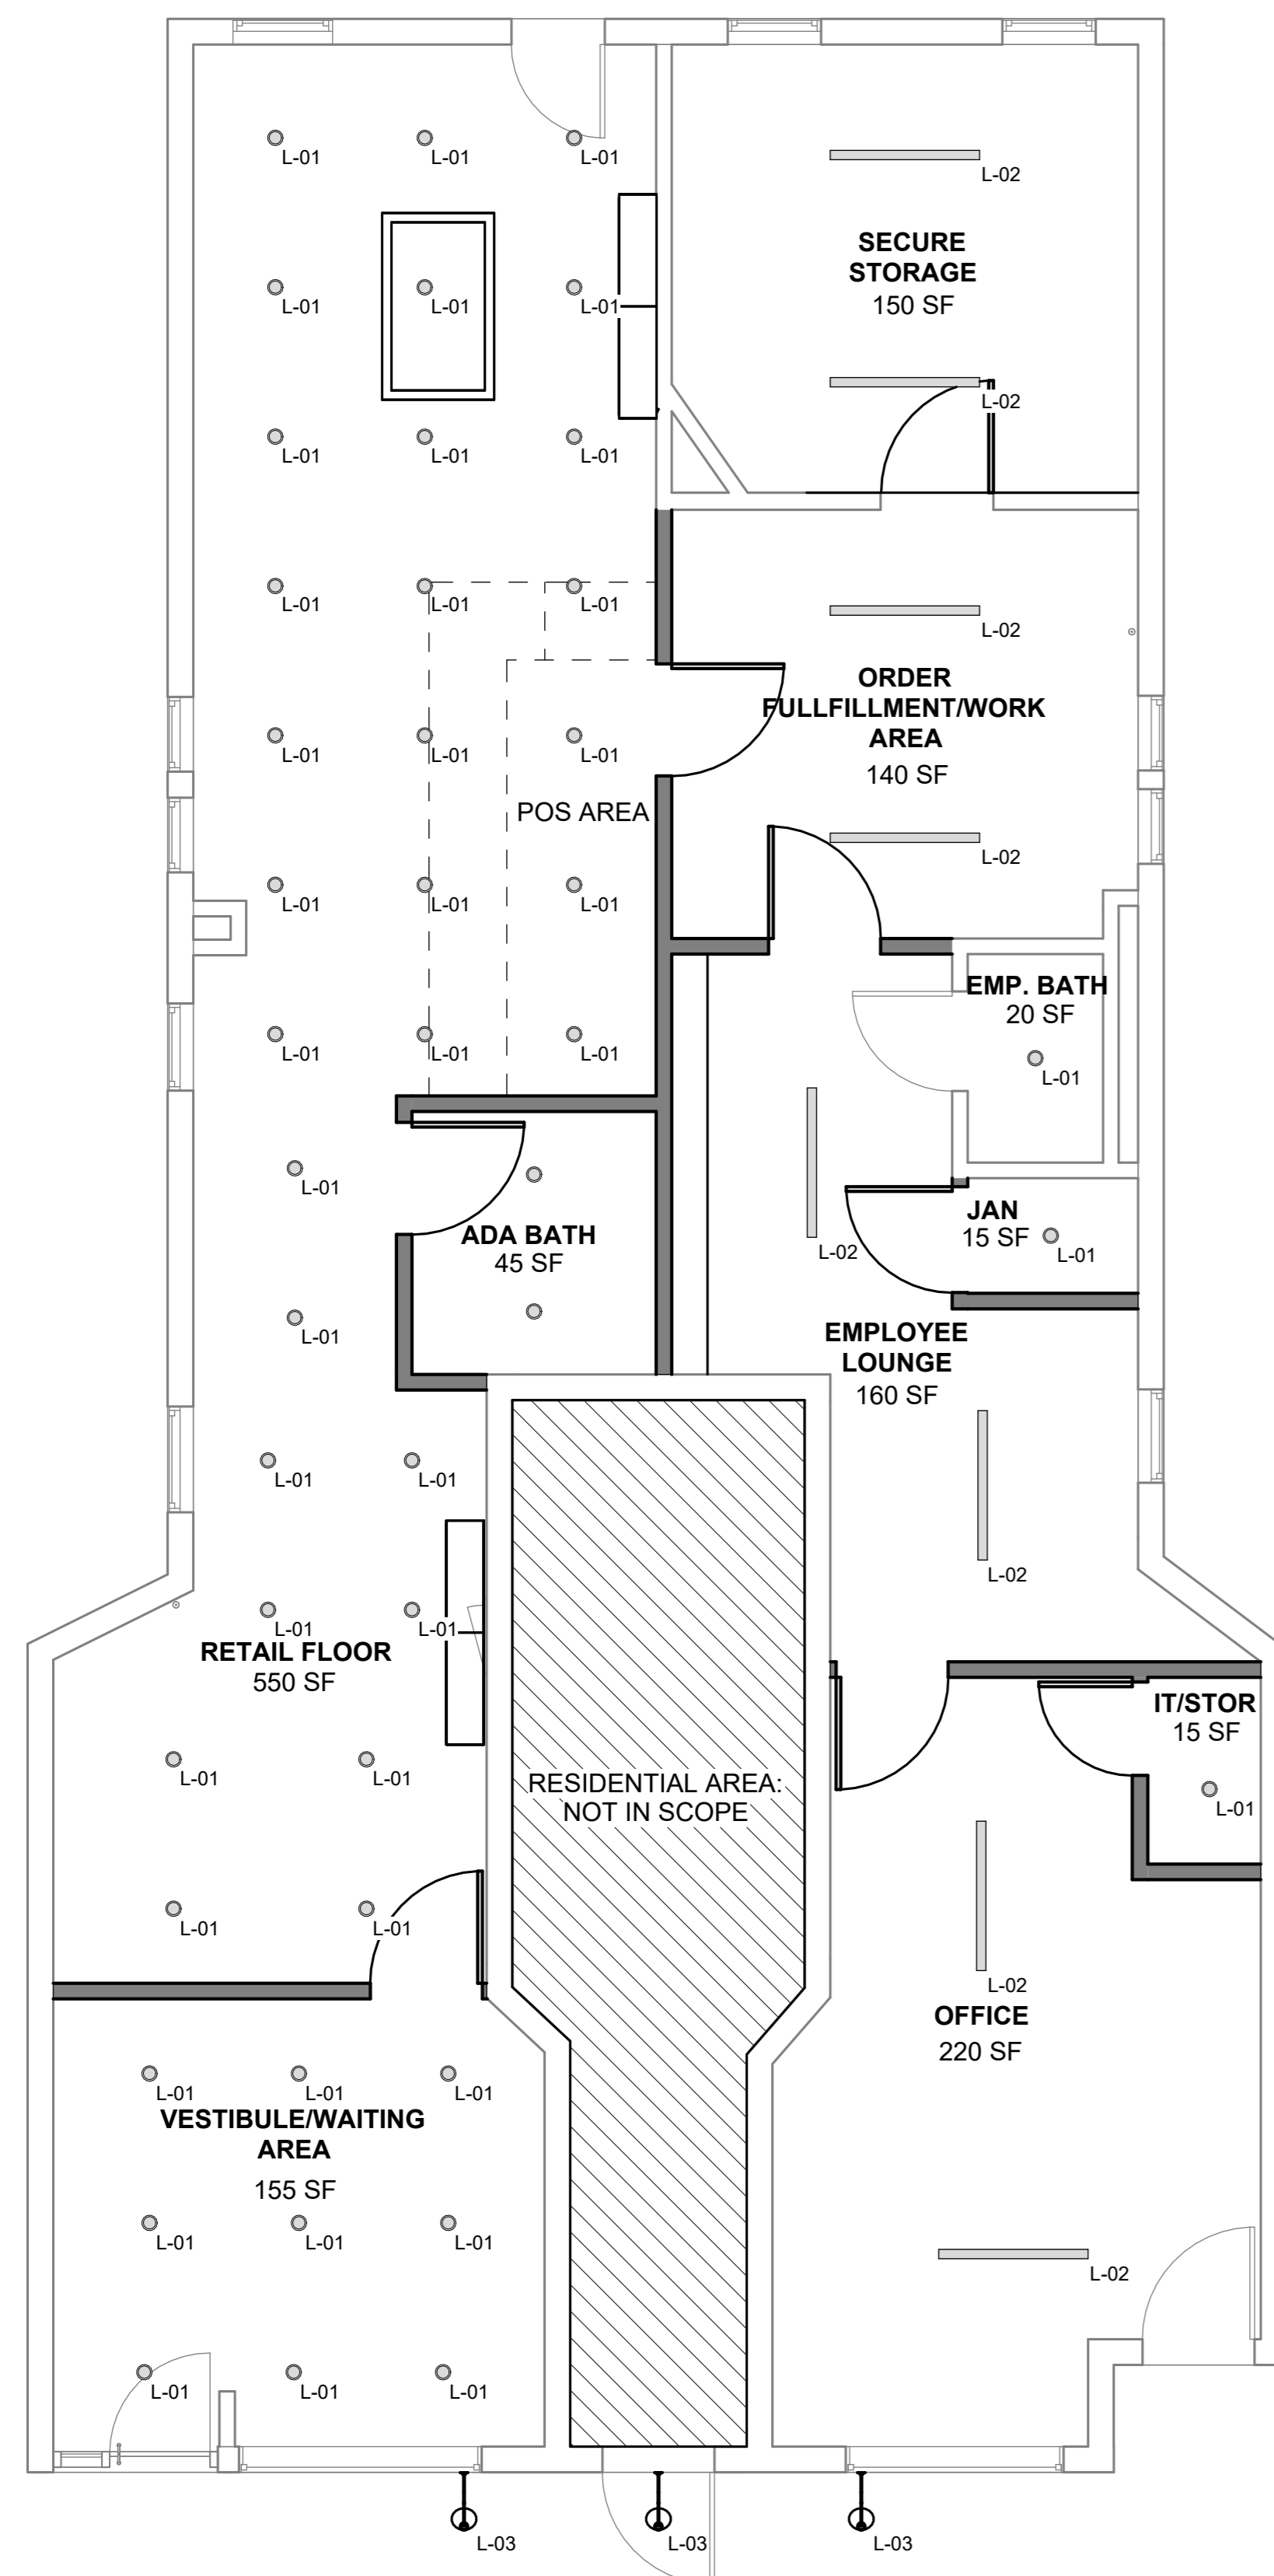

1 FIRST FLOOR - PROPOSED LIGHTING PLAN
1/4" = 1'-0"