
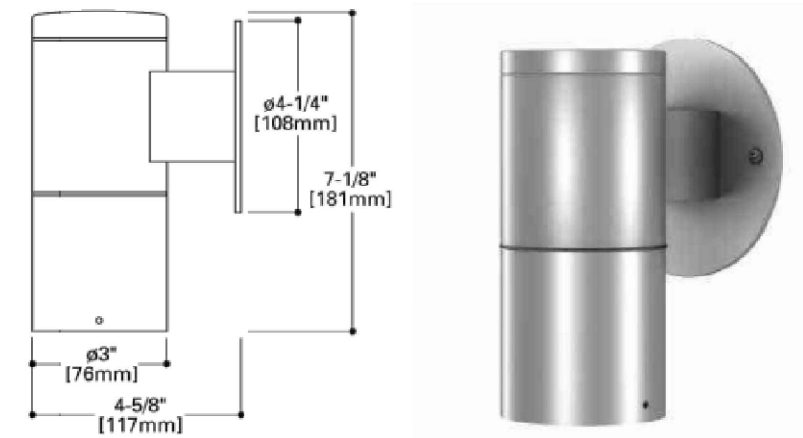


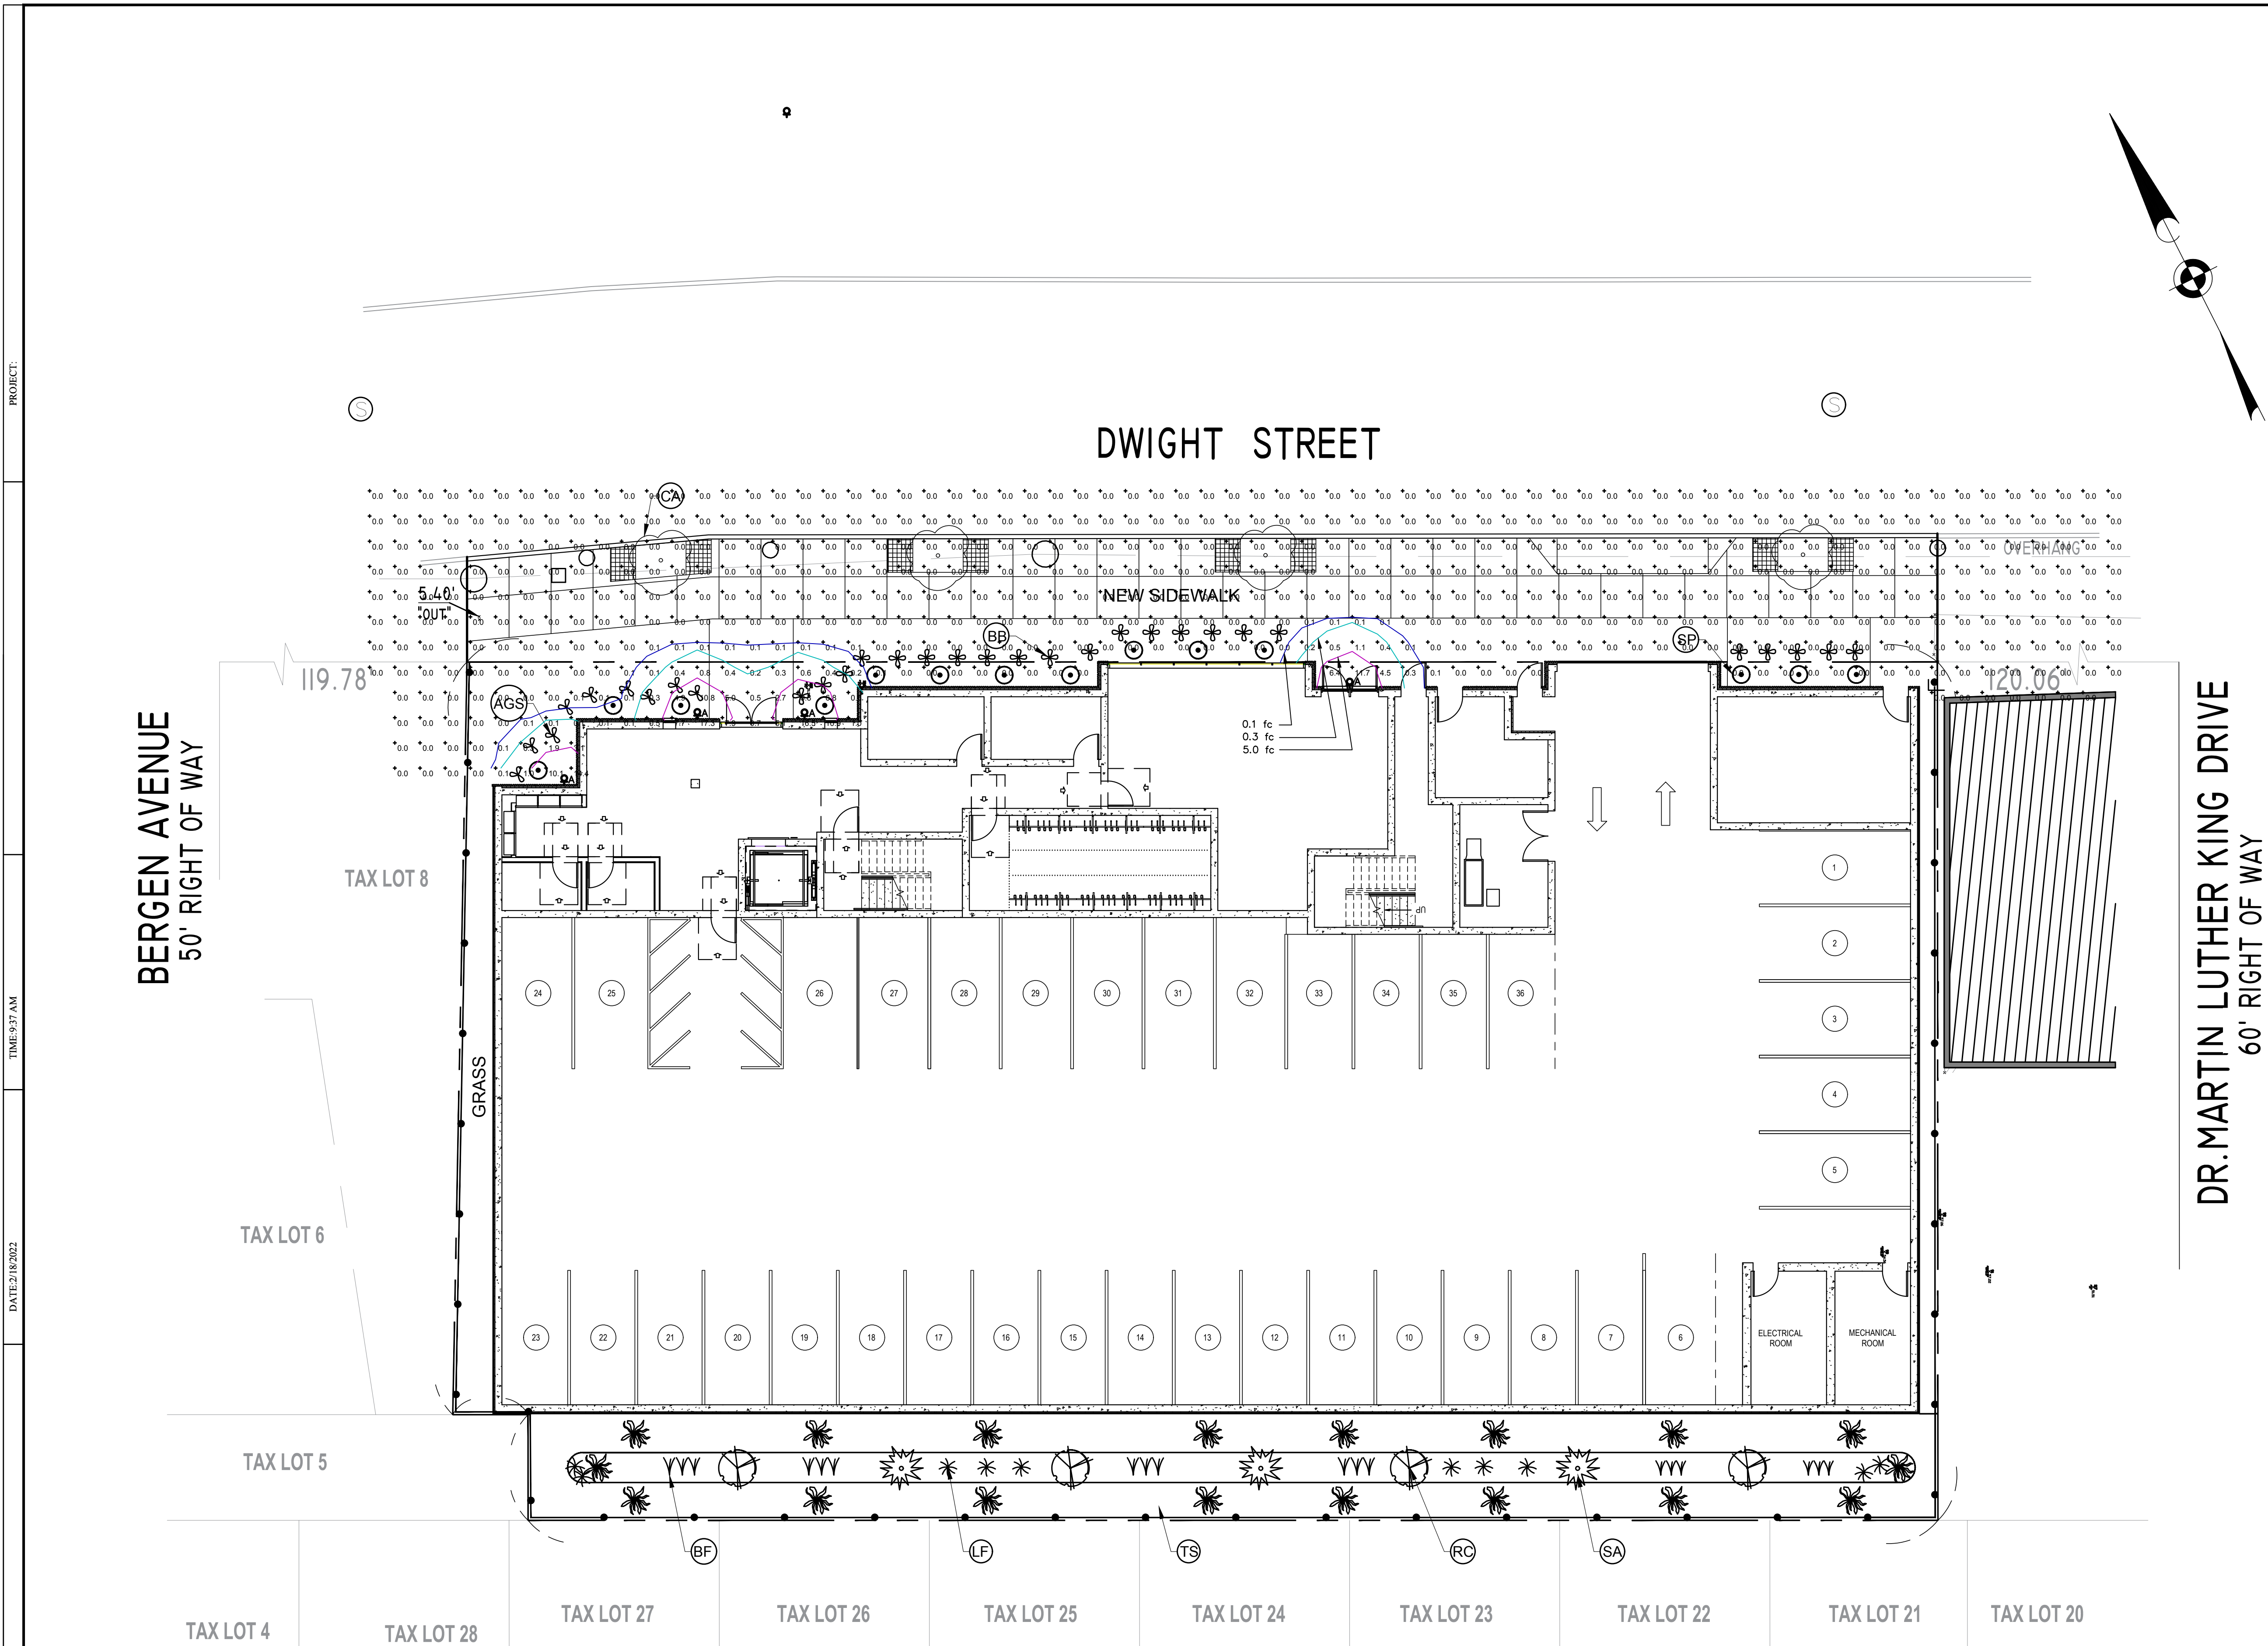



MODEL NOTES:
1. EXTERIOR LIGHTING SHALL BE SHIELDED, SO AS NOT TO SHINE ON ADJACENT PROPERTIES. DOWNLIGHT WALL FIXTURE.

ARCHITECTURAL DOWN LIGHT
N.T.S.

LIGHTING PLAN
SCALE: 1"=10'

LIGHTING SCHEDULE

TYPE	QTY	CATALOG NO.	DESCRIPTION	LLF	WATT	COMMENTS
	4	CK-LED-X21-FL-9-C	ARCHITECTURAL DOWN LIGHT BY BK LIGHTING	1.00	17.7	MOUNTED ON BLDG AT 8' FROM GROUND

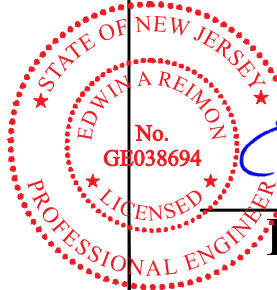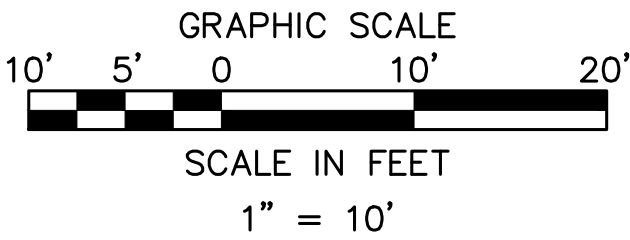

225 DWIGHT STREET
BLOCK 24904 LOT 9

City of Jersey CityHudson CountyNew Jersey

LIGHTING PLAN

Edwin A. Reimon, P.E., C.M.E.
251 Ridge Road
Lyndhurst, NJ 07071

Edwin A. Reimon, P.E.
NJ PROFESSIONAL ENGINEER NO. 24GE03869400

Job #: 2021 - 4000
Scale: AS SHOWN
Date: 2/17/2022

Drawn By: B.A.C.
Checked By: E.A.R.

Sheet #: L-1